

PARTS LIST


ITEM NO	COMPONENT	PART NO.	DESCRIPTION	MANUFACTURER	QTY	REMARKS
①	FOUNTAIN	-	56"H x 32"W 315lbs. OBTUSE FOUNTAIN - GFRC	TREVI	1	COLOR OPTIONAL
②		-	18" DIA BALL - GFRC	TREVI	1	COLOR OPTIONAL
③		-	2'8 1/4"W x 2'8 1/4"L x 8 3/8"H SQUARE BASE - GFRC	TREVI	1	COLOR OPTIONAL
④		-	2'4 3/4"W x 2'4 3/4"L x 6 1/8"H SQUARE BASEN - PLASTIC	TREVI	1	COLOR BLACK
⑤	TUBING	-	3/4" DIA PVC COUPLER SOCKET END	-	2	PRE-INSTALLED
⑥		-	1/2" DIA x 1'LG PVC PIPE PLAIN END	-	1	PRE-INSTALLED
⑦		-	3/4"x1/2" DIA PVC CONCENTRIC REDUCER SOCKET END	-	1	PRE-INSTALLED
⑦	PARTS BAG	A115	3/4"x1/2" DIA PVC CONCENTRIC REDUCER SOCKET END	-	2	
⑧		A115	1/2" DIA BALL VALVE PVC SCH. 40 150 PSI	-	1	
⑨		A115	5/8" I.D. x 10'LG TUBING - CLEAR VINYL PLAIN END	-	1	
⑩		A115	5/8" I.D. x 24'LG TUBING - CLEAR VINYL PLAIN END	-	1	
⑪		A115	SHIM PLASTIC	EZ - SHIM	6	
⑫	PUMP	-	1"x1/2" DIA THREADED, SLIP DISCHARGE ADAPTER WITH VENTURI	COMMODITY AXIS INC.	1	
⑬		-	VA3300, 950 GPH SUBMERSIBLE PUMP	COMMODITY AXIS INC.	1	

NOTE:

Electrical supply must conform with local & national regulation/codes.
If in doubt consult an electrician.


To ease connections hot water may be used to soften PVC tubing.
Pump and plumbing details may vary.

Precautions should be taken to prevent damage from water freezing in reservoir.

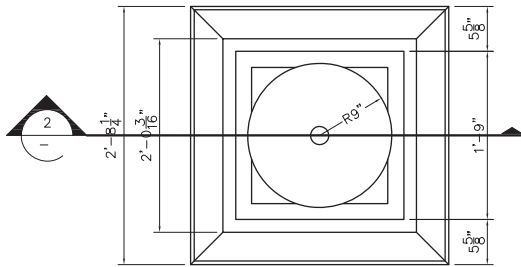



1 PLAN VIEW

SCALE: 1/2"=1'

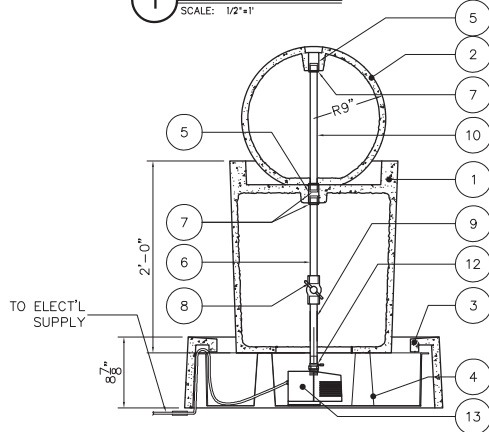

2 ELEVATION

SCALE: 1/2"=1'

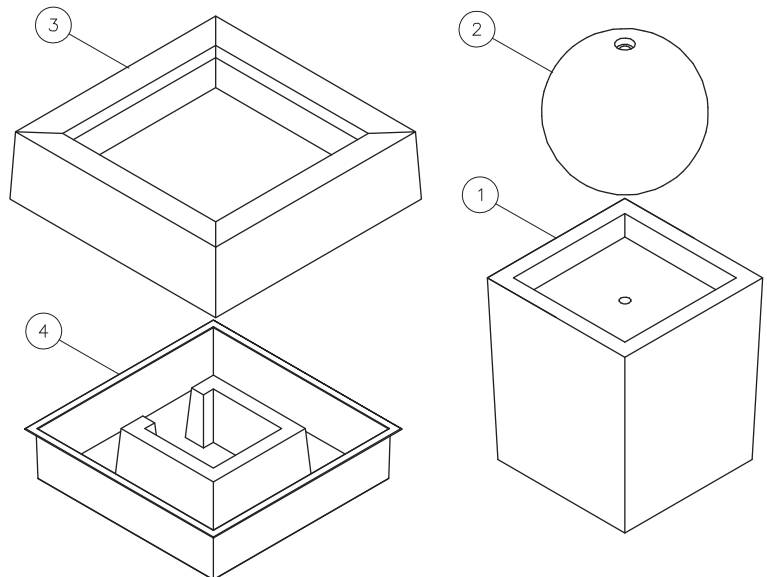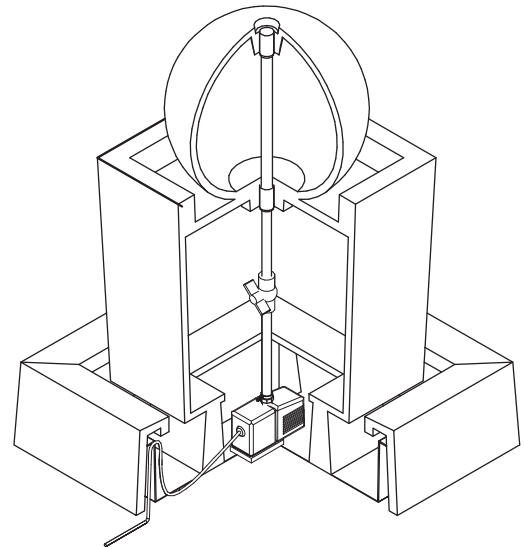

995 Governor Dr. #103
El Dorado Hills, CA 95762
866 382-8600

info@yardart.com

CONTENT
OBT-F-BALL
OBTUSE FOUNTAIN WITH BALL

PROJECT OBT-F-BALL

DRAWING NO
OBT-F-BALL
SHOP

SHEET. NO. 1 OF 1