

PARTS LIST


ITEM NO	COMPONENT	PART NO.	DESCRIPTION	MANUFACTURER	QTY	REMARKS
①	FOUNTAIN	—	40" x 17"W x 17"L ROCKET FOUNTAIN — GFRC	TREVI	1	COLOR OPTIONAL
②		—	12"W x 12"L x 8"D MINI CAP — GFRC	TREVI	1	COLOR OPTIONAL
③		—	2'8 1/4"W x 2'8 1/4"L x 8 5/8"H SQUARE BASE — GFRC	TREVI	1	COLOR OPTIONAL
④		—	2'4 3/4"W x 2'4 3/4"L x 6 13/32"H SQUARE BASEN — PLASTIC	TREVI	1	COLOR OPTIONAL
⑤	TUBING	—	3/4" DIA PVC COUPLER SOCKET END	—	1	PRE-INSTALLED
⑥		—	3/4"x1/2" DIA PVC CONCENTRIC REDUCER SOCKET END	—	1	PRE-INSTALLED
⑦		—	1/2" DIA x 20"LG PVC PIPE PLAIN END	—	1	PRE-INSTALLED
⑧	PARTS BAG	A101	1/2" DIA BALL VALVE PVC SCH. 40 150 PSI	—	1	
⑨		A101	5/8" I.D. x 10"LG TUBING — CLEAR VINYL PLAIN END	—	1	
⑩		A101	SHIM PLASTIC	EZ — SHIM	4	
⑪	PUMP	—	1"x1/2" DIA ADAPTER THREADED	JEAN TECH INC.	1	
⑫		—	VA2600, 700 GPH SUBMERSIBLE PUMP	JEAN TECH INC.	1	

NOTE:

Electrical supply must conform with local & national regulation/codes.
If in doubt consult an electrician.


To ease connections hot water may be used to soften PVC tubing.
Pump and plumbing details may vary.

Precautions should be taken to prevent damage from water freezing in reservoir.

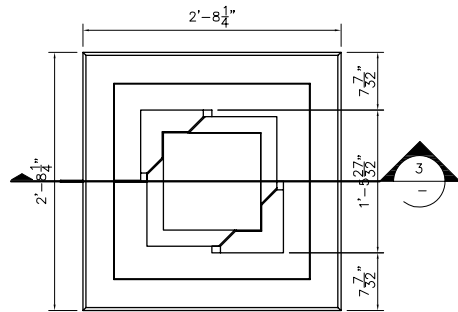


1 PLAN VIEW

SCALE: 1/2"=1'

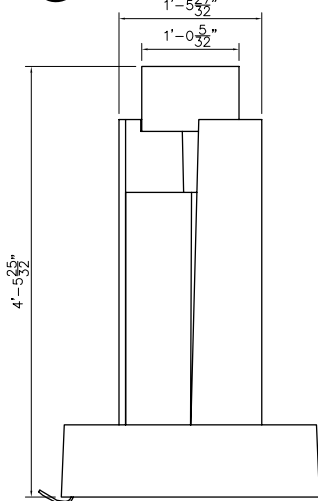

2 ELEVATION




SCALE: 1/2"=1'

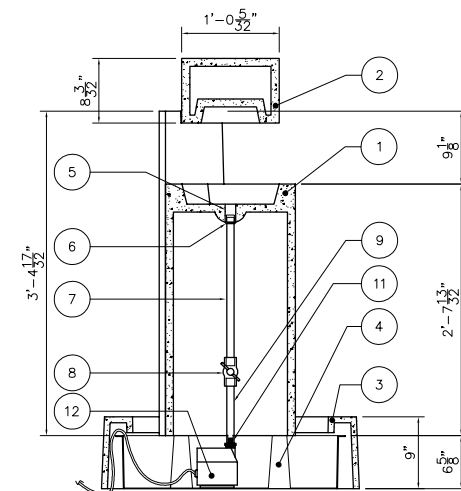

3 SECTION

SCALE: 1/2"=1'

TO ELECT'L
SUPPLY

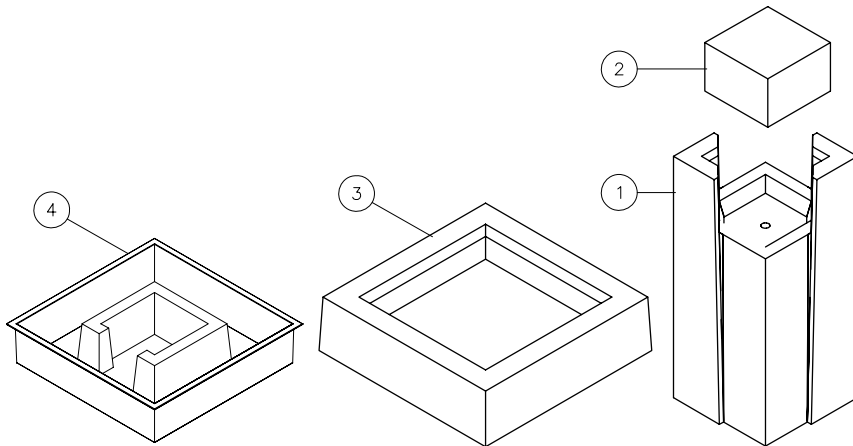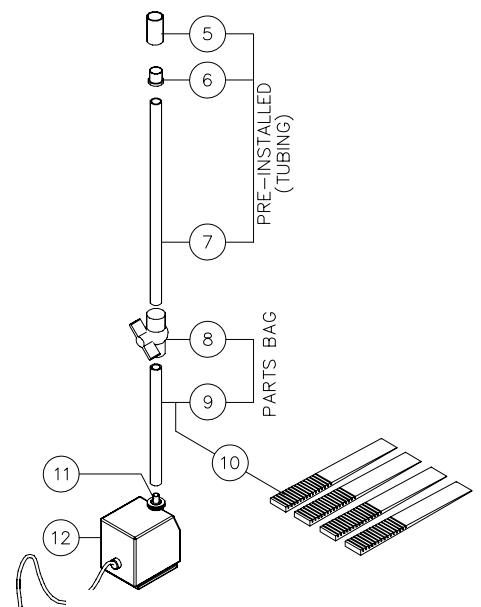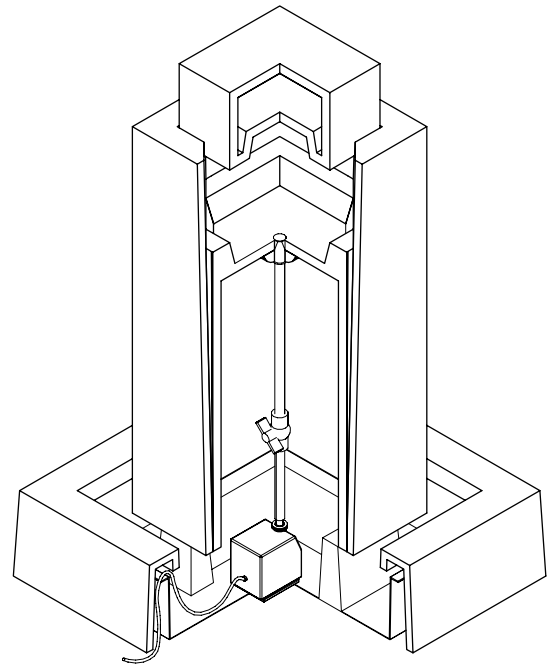

995 Governor Dr. #103
El Dorado Hills, CA 95762
866 382-8600

info@yardart.com

CONTENT
RCKT
ROCKET FOUNTAIN

PROJECT RCKT

DRAWING NO
RCKT
SHOP

SHEET. NO. 1 OF 1